



**DIMMER & SWITCH BANK SA**

SYMBOL	SWITCH	DIMMER	CONNECTED LOAD (WATTS)	CODE REQUIRED LOAD (WATTS)	LABEL
a	ATMOS 2,200W 2P G.M.T.R.	ATMOS 2,200W 2P G.M.T.R.	4000	4000	"LUMINOUS CLG"
b					
c		ATMOS #A 15-19	900	900	"PLATFORM"
d		10	600	600	
e		10	600	600	
f		10	600	600	
g		20	450 (1440 FUTURE)	900 (1440 FUTURE)	"SANCTUARY"
h		15	750 (1200 FUTURE)	900 (1440 FUTURE)	"SANCTUARY"
j		10	750	900	"CHOIR"
k					
l					
m					
n					
r	S <sup>2</sup>		350	350	"EXITS"

**PANEL B**

CIR BREAKER NO	AMP	OUTLET	LOCATION	LOAD WATTS
1	30	3	CLOSET - REMOTE DIMMER	2000
2	20	1	SANCTUARY - PLATFORM	900
3	20	1	SANCTUARY - PLATFORM	2000
4	20	1	SANCTUARY - PLATFORM	1000
5	20	1	SANCTUARY	2000
6	20	1	SANCTUARY	2000
7	20	1	SPARE	1000
8	20	1	PLATFORM	1000
9	20	1	OFFICE, VTL, PRESS, OUTSIDE	1000
10	20	1	OFFICE, VTL, PRESS, OUTSIDE	1000
11	20	1	OFFICE, CLASS	1440
12	20	1	OFFICE, CLASS	1000
13	20	1	OFFICE - DH-2	1000
14	20	1	SANCTUARY OFFICE	1000
15	20	1	OFFICE - DH-1	1750
16	20	1	OFFICE - DH-1	1750
17	20	1	STORAGE - P.A. AMPLIFIER	200
18	20	1	OFFICE - DH-1	1750
19	20	1	SPARE - FUTURE LIGHTING	1000
20	20	1	SPARE - FUTURE LIGHTING	1750
21	20	1	OUTSIDE - FUTURE LIGHTING	1000
22	20	1	OUTSIDE - FUTURE LIGHTING	1000
23	20	1	OUTSIDE - FUTURE LIGHTING	1000
24	20	1	OUTSIDE - FUTURE LIGHTING	1000
25	20	1	OUTSIDE - 1/4HP PUMP	1000
26	20	1	SPACE	1000
27				
28				
29				
30				
31				
32				
33				
34				
35				
36				
37				
38				
39				
40				
41				
42				
TOTALS				11,142

TOTAL = 32,020 WATTS = 89 AMPS @ 208V, 3 @ 225 AMP BUS

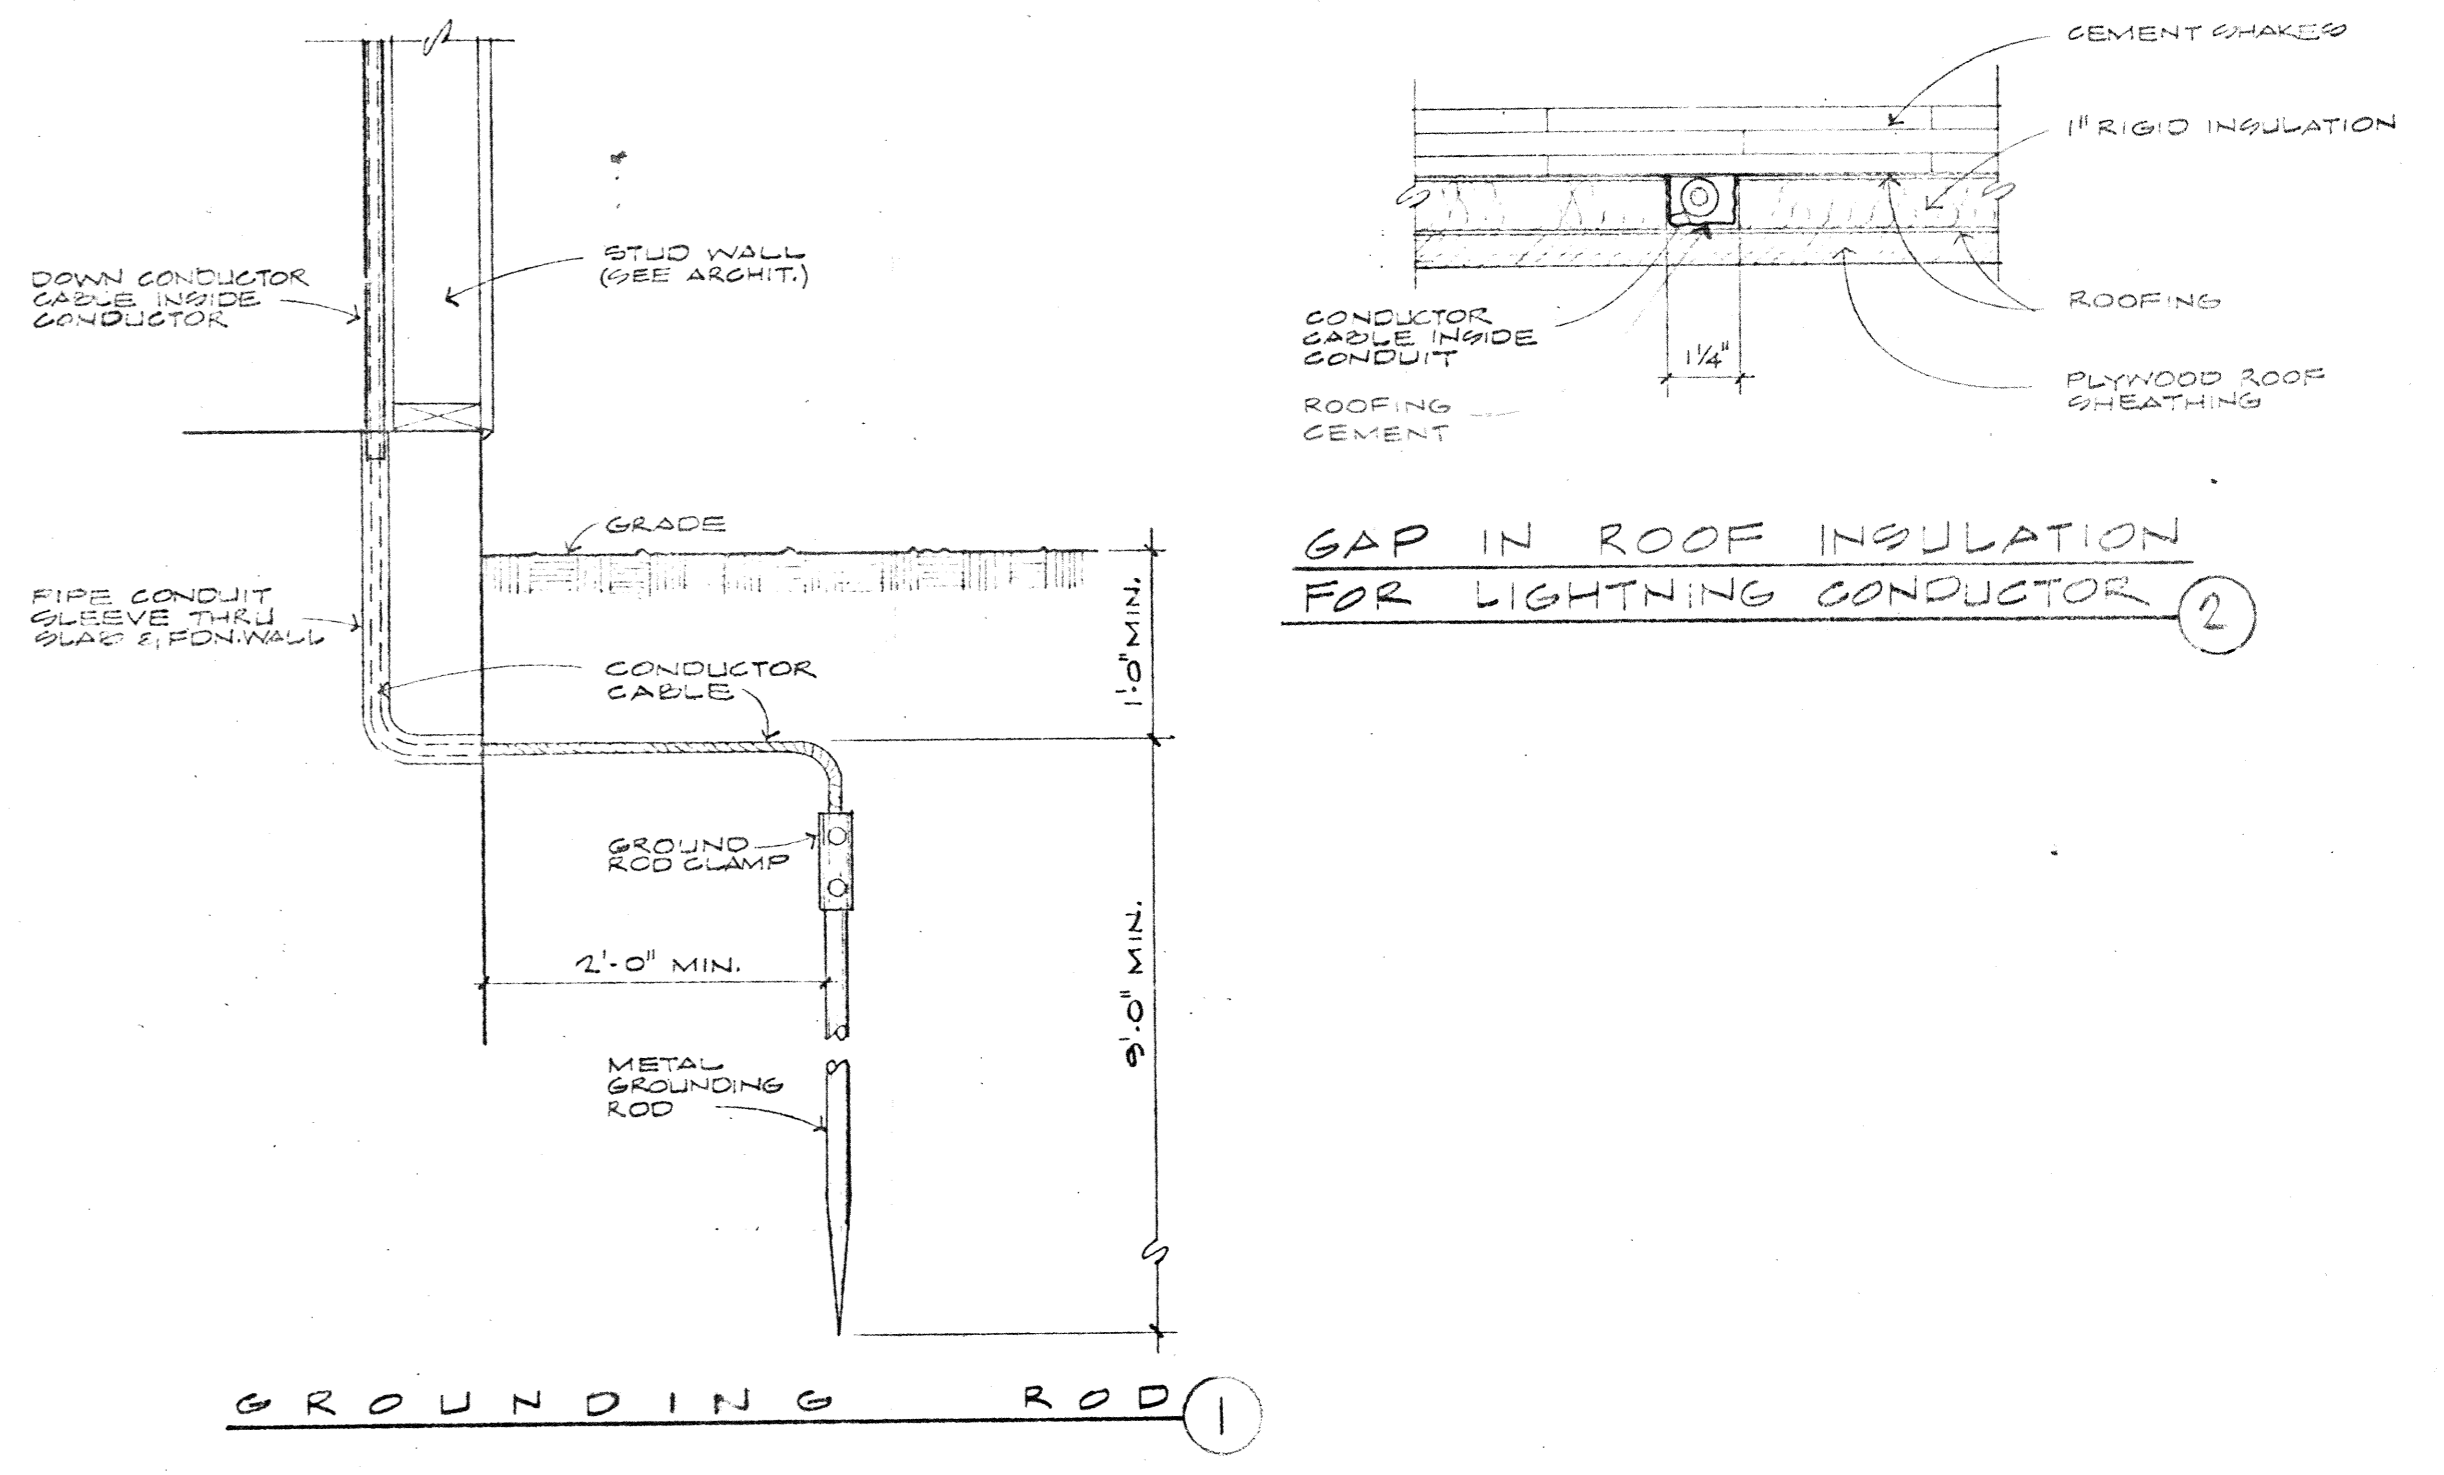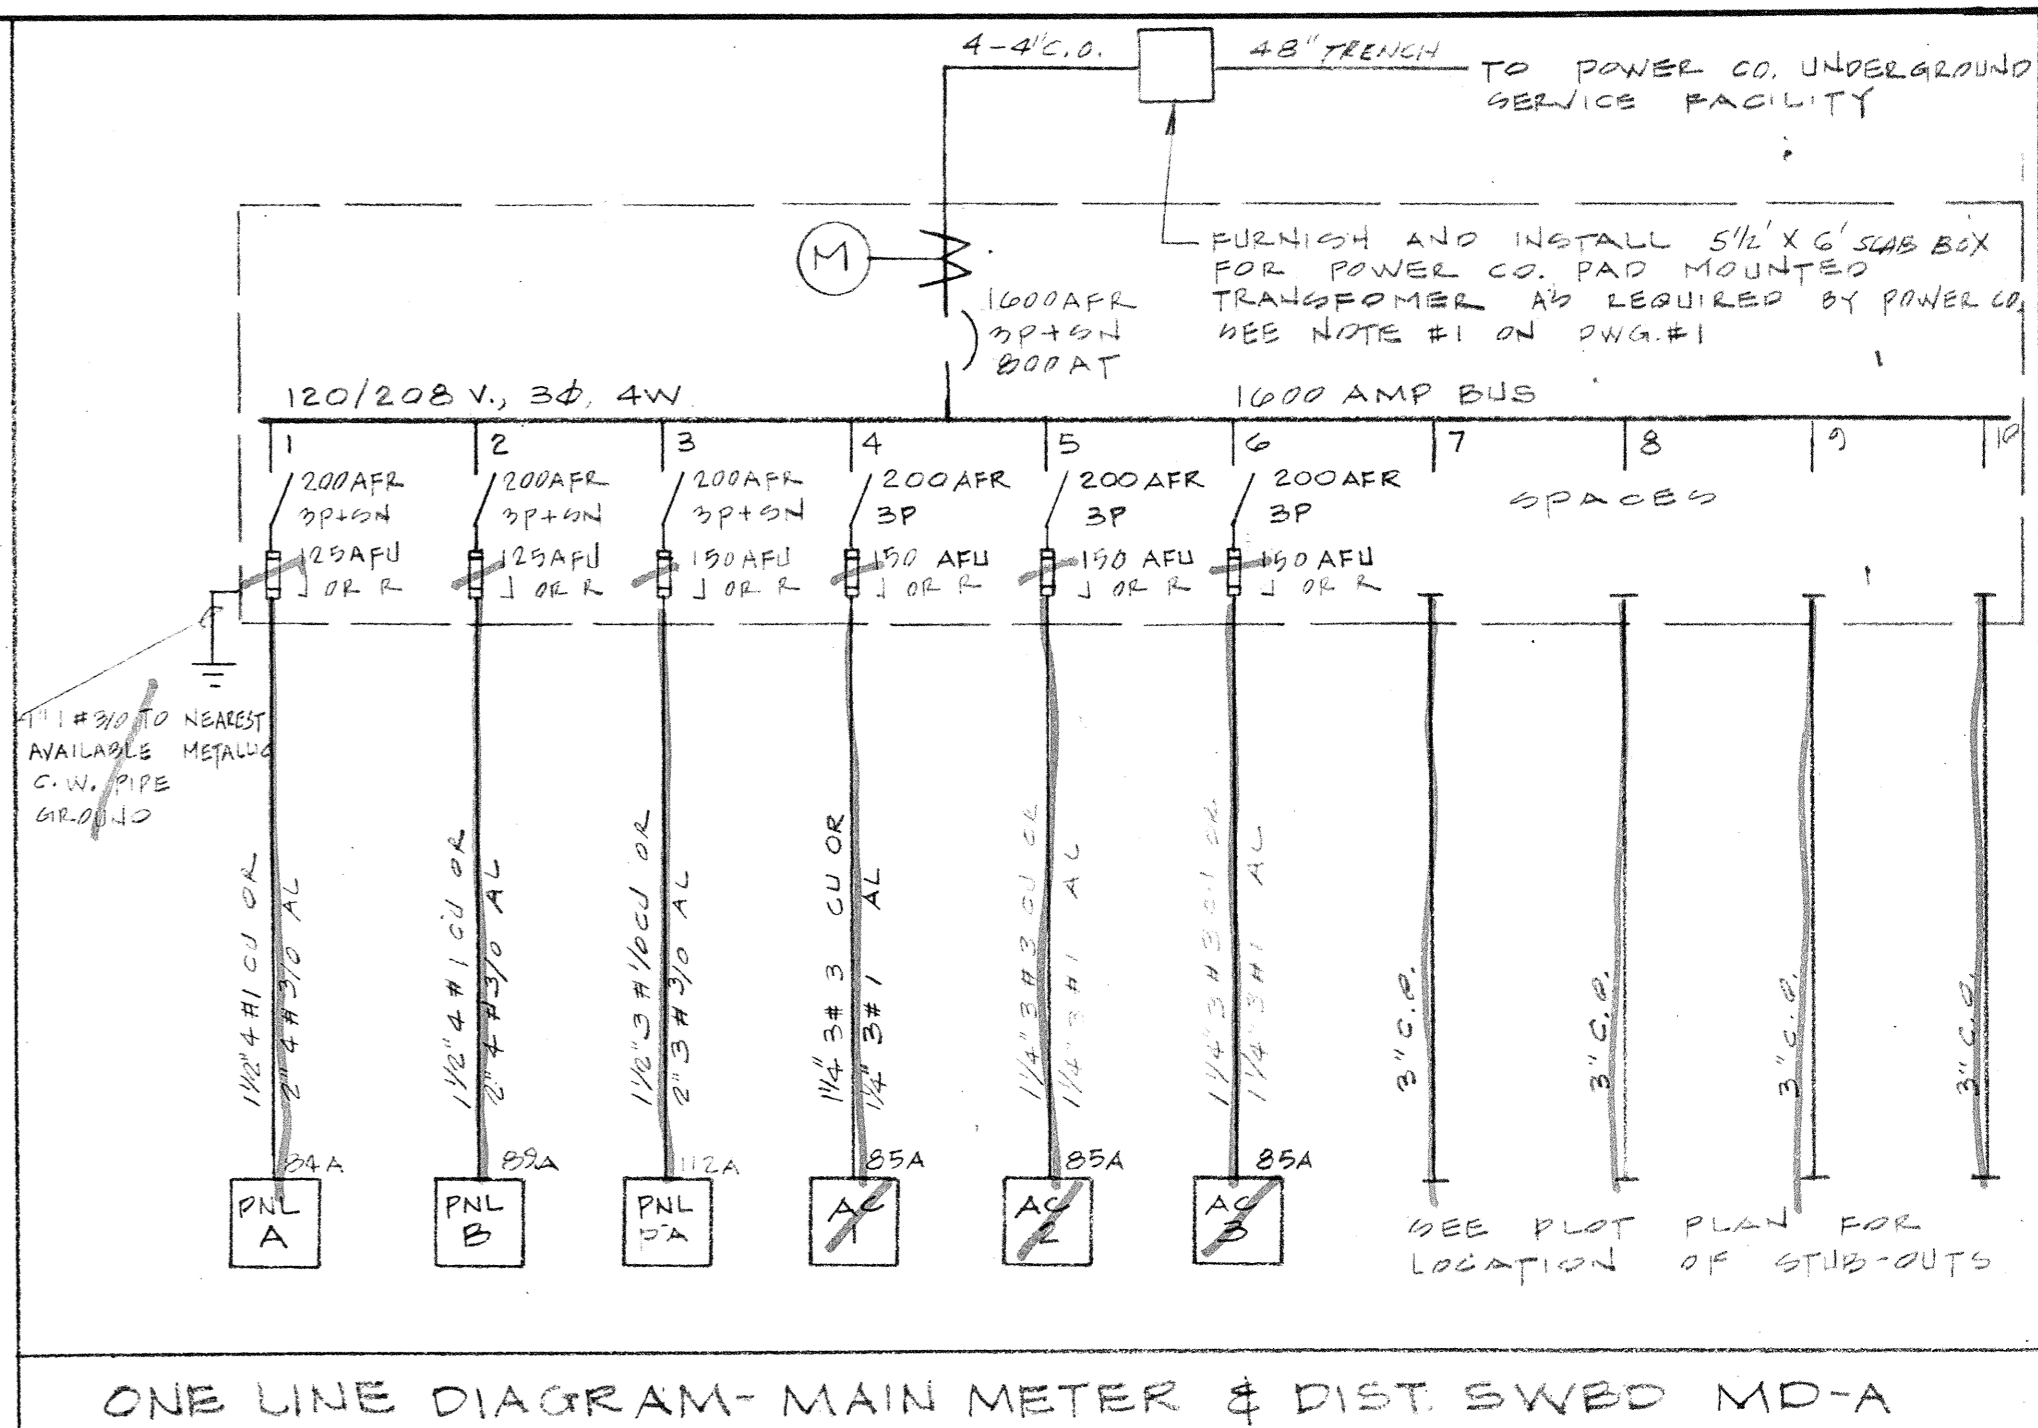

**ELECTRICAL-LIGHTING & POWER PLAN** SCALE 1/8"=1'-0"

**STAN WOJTAN & ASSOCIATES**  
CONSULTING ELECTRICAL ENGINEERS  
8720 RIVERSIDE DRIVE, SHERMAN OAKS, CALIF. 91764  
JOB NO. 4175

**LASALIA and SQUIRE AIA**  
ARCHITECTS  
5441 TOPANGA CANYON BLVD WOODLAND HILLS CALIFORNIA 91367-0633

**REVISIONS**

DATE	DESCRIPTION

**CONEJO VALLEY CHURCH OF CHRIST**  
SANCTUARY BUILDING  
P.O. BOX 726 · THOUSAND OAKS, CALIFORNIA

**EE-2**